

 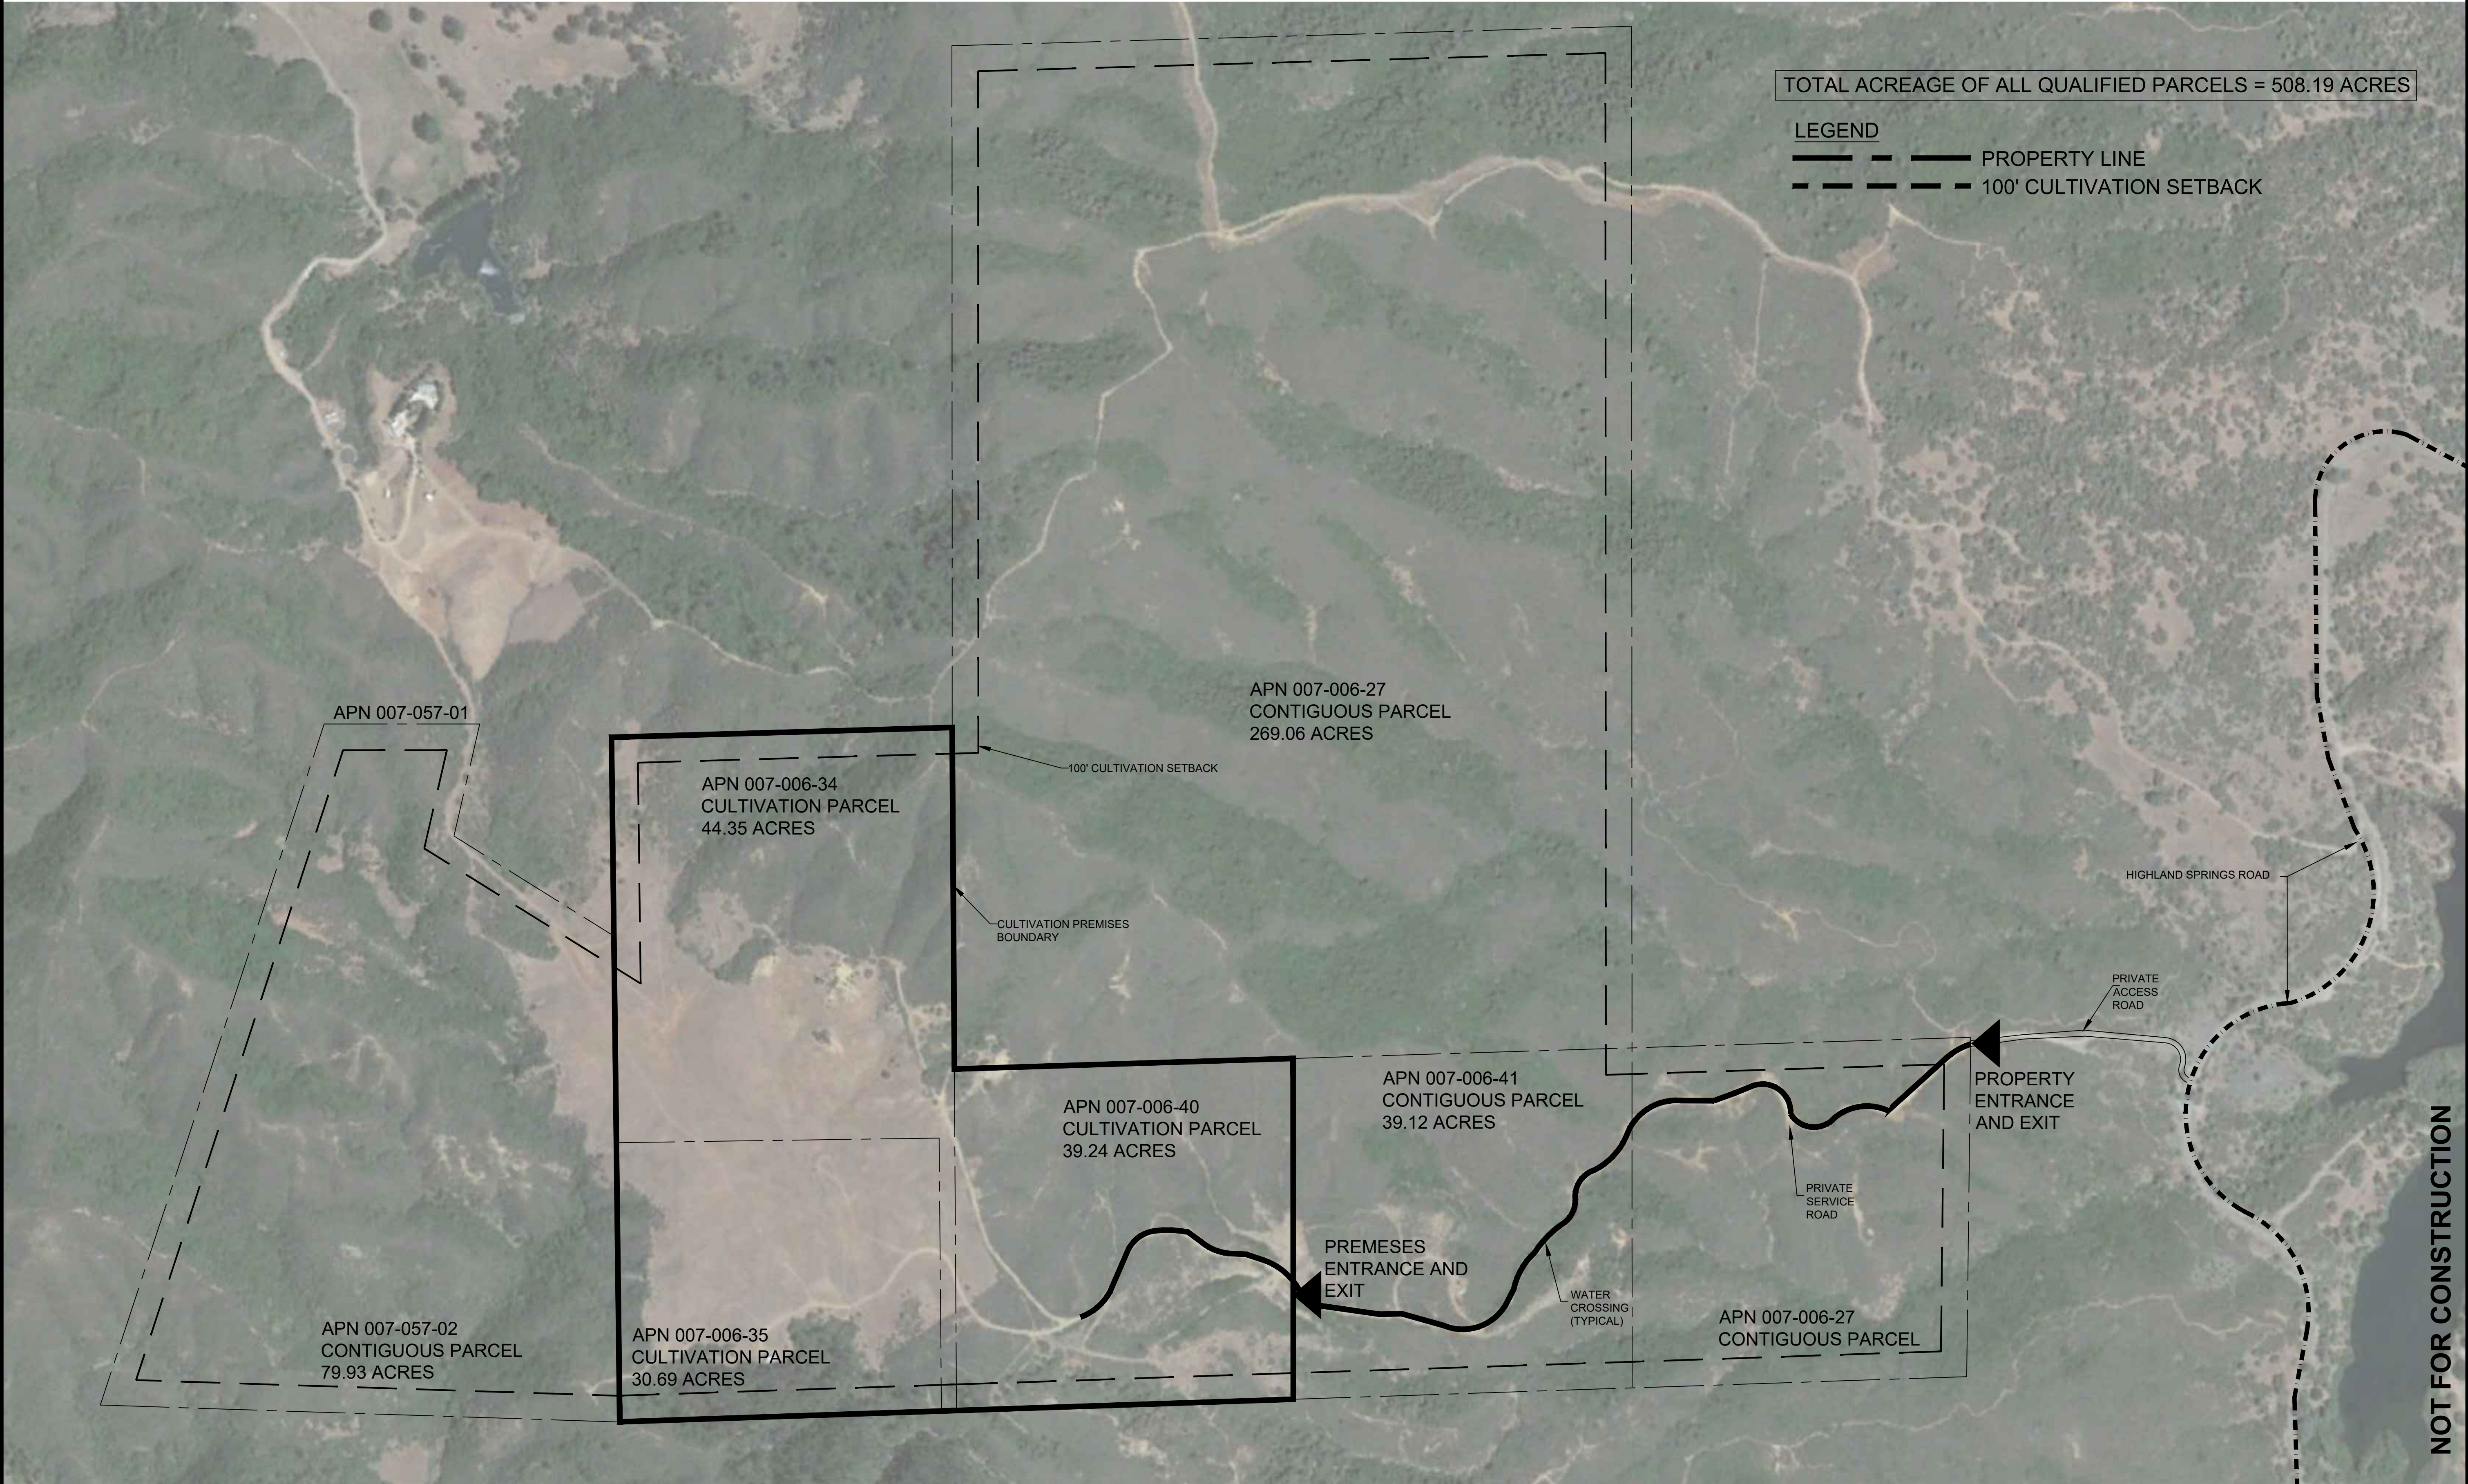


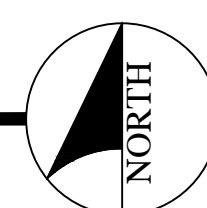

1 EXISTING AREA SITE PLAN

1" = 300'



HIGHLAND FARMS, LP
CANNABIS CULTIVATION OPERATION
7408, 7533, 7527 & 7634, 7746 HIGHLAND SPRINGS RD
AND 7257 & 7357 AMBER RIDGE ROAD
LAKEPORT, CA 96453

DATE ISSUED 10 NOV 23
INITIAL SUBMITTAL 27 OCT 20

DRAWN BY WB
CHECKED BY WB
JOB NO. 21038


GS-01



CULTIVO
EXPERIENCE • DESIGN • INNOVATION
CULTIVOINC.COM




LAKE CO
DEVELOPMENT
CONTACT:
AUTUMN KARCEY, CEO
(530) 379-8588
AUTUMN@LAKECODEVELOPMENT.COM

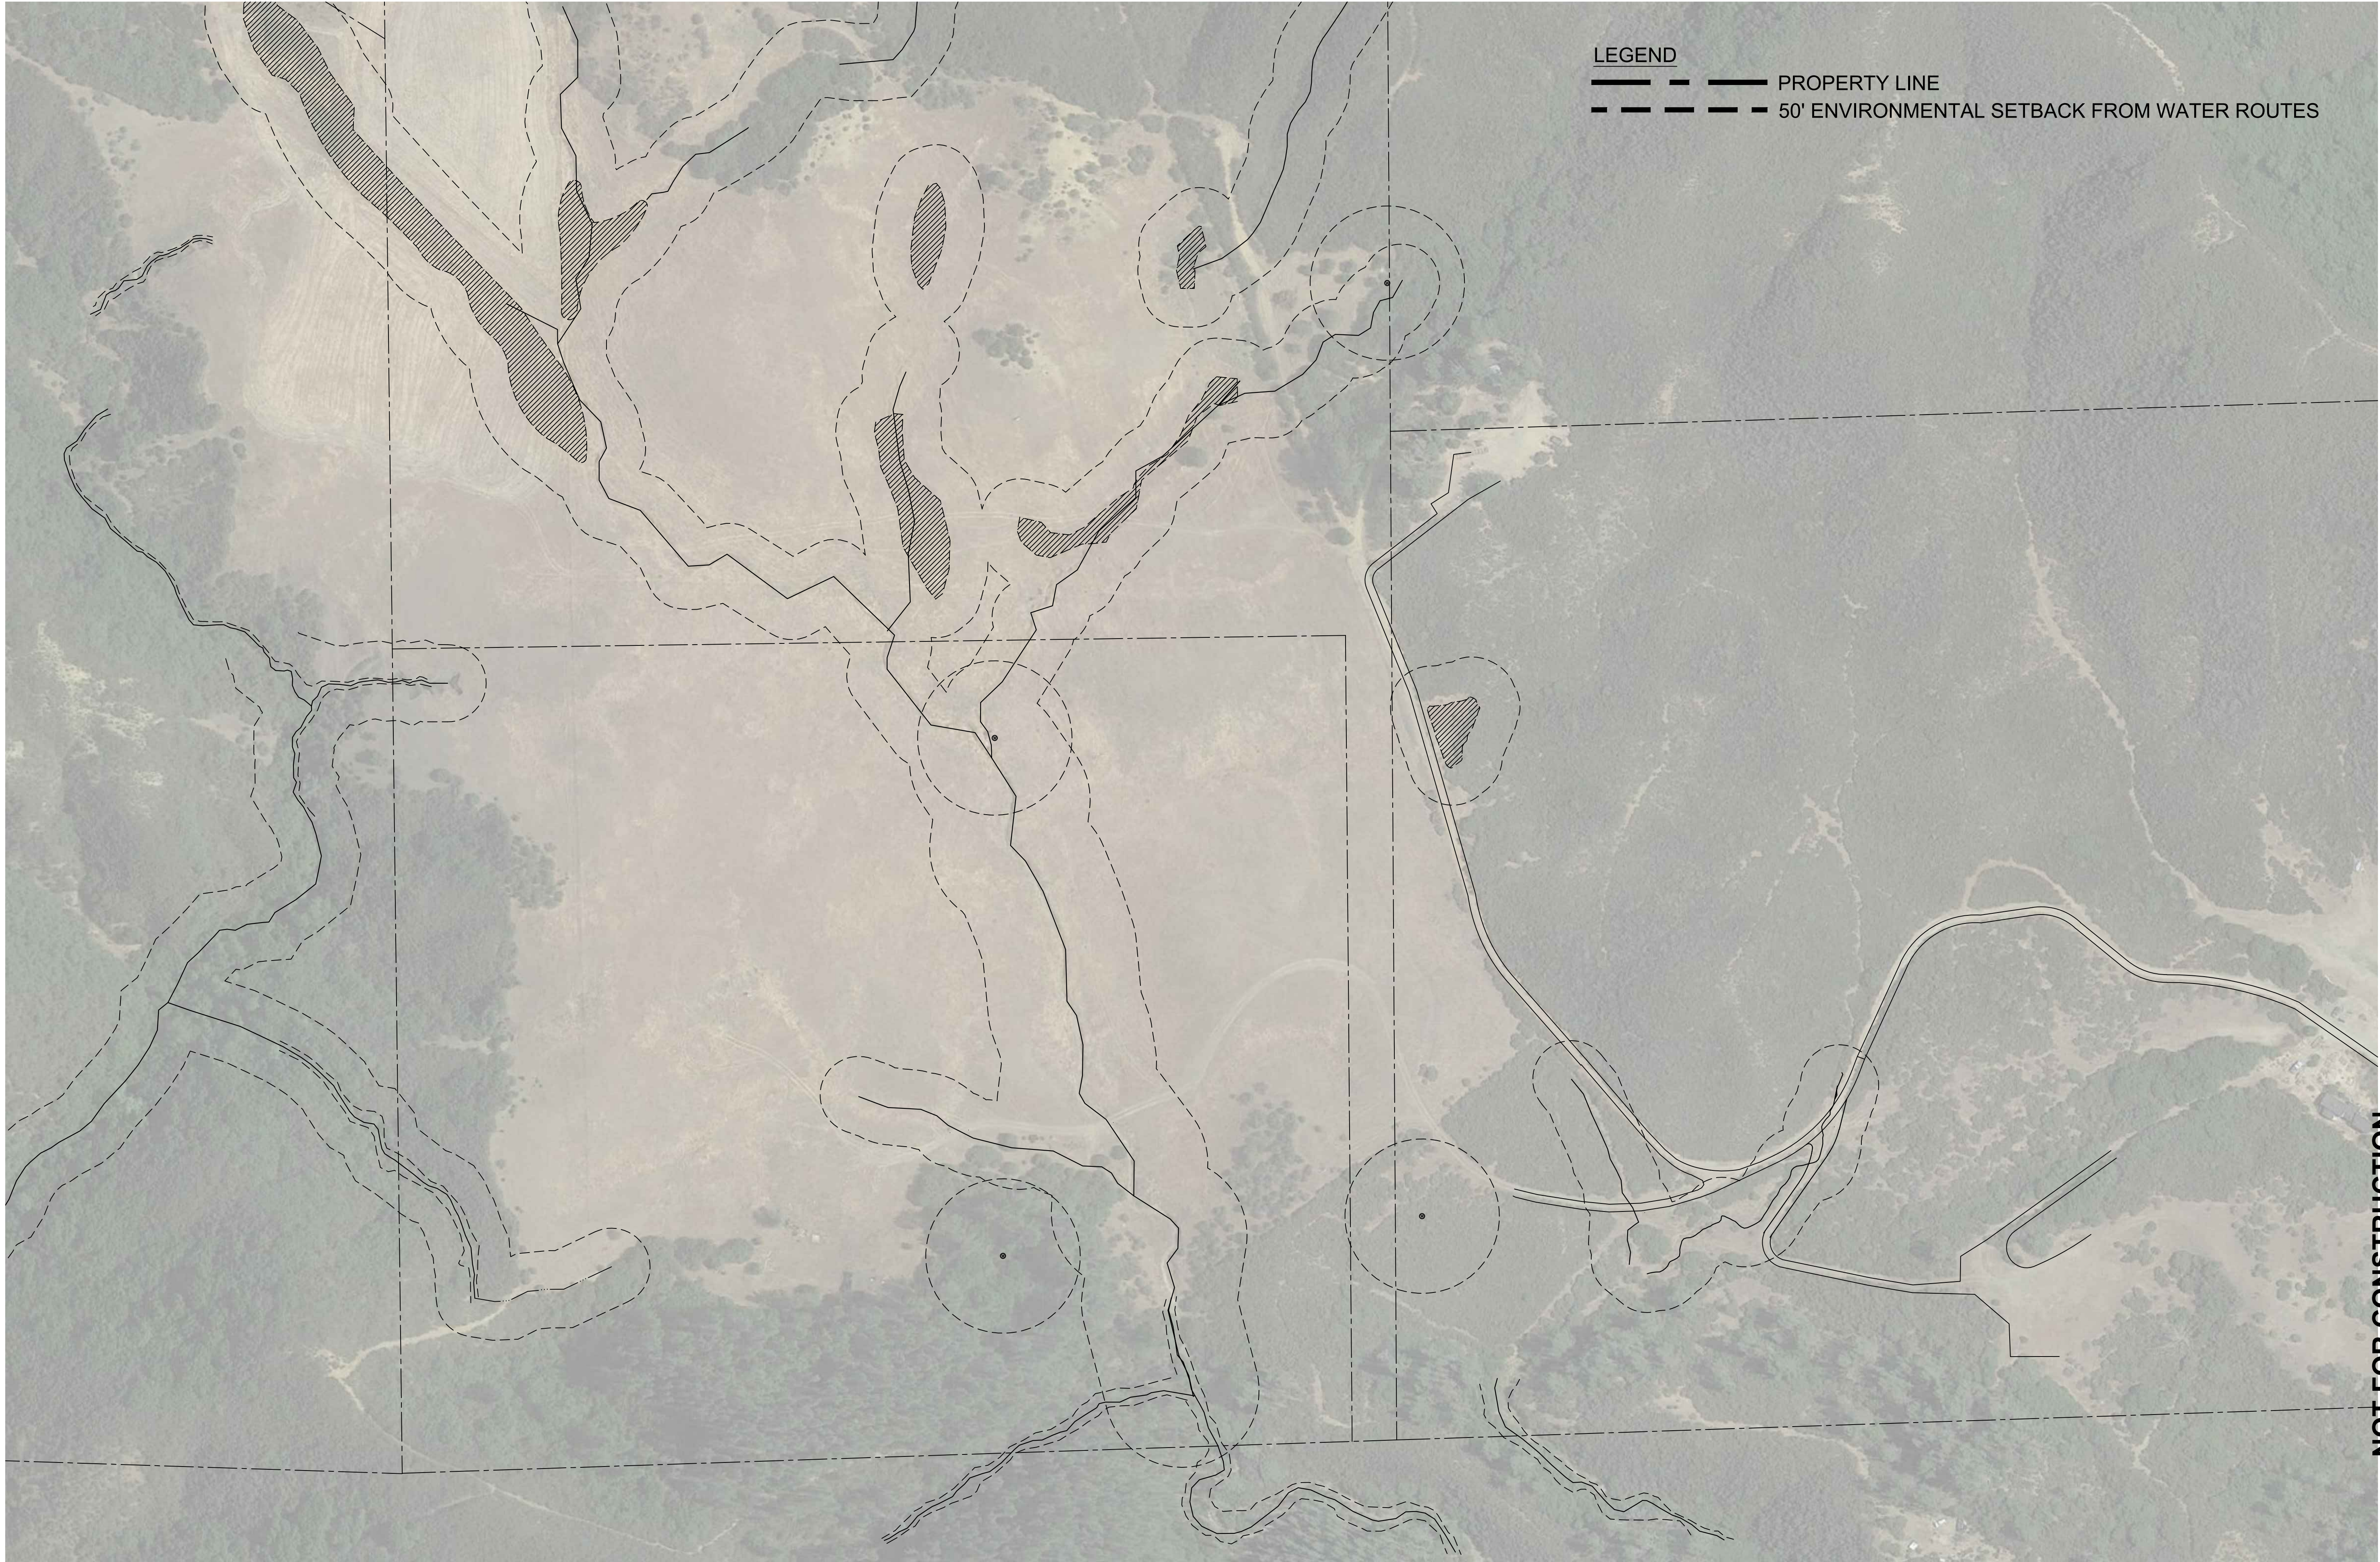

LEGEND
——— PROPERTY LINE
- - - 50' ENVIRONMENTAL SETBACK FROM WATER ROUTES

NOT FOR CONSTRUCTION

1 ENVIRONMENTAL SETBACK PLAN
1" = 100'

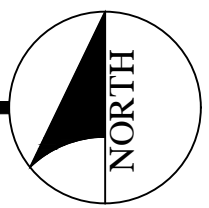

HIGHLAND FARMS, LP
CANNABIS CULTIVATION OPERATION
7408, 7533, 7527 & 7634, 7746 HIGHLAND SPRINGS RD
AND 7257 & 7357 AMBER RIDGE ROAD
LAKEPORT, CA 95453

DATE ISSUED 10 NOV 23
INITIAL SUBMITTAL 27 OCT 20

DRAWN BY WB
CHECKED BY WB
JOB NO. 21038




LAKE CO
DEVELOPMENT

CONTACT:
AUTUMN KARCEY, CEO
(530) 379-8588
AUTUMN@LAKECODEVELOPMENT.COM

ENVIRONMENTAL SETBACK PLAN


EX-01

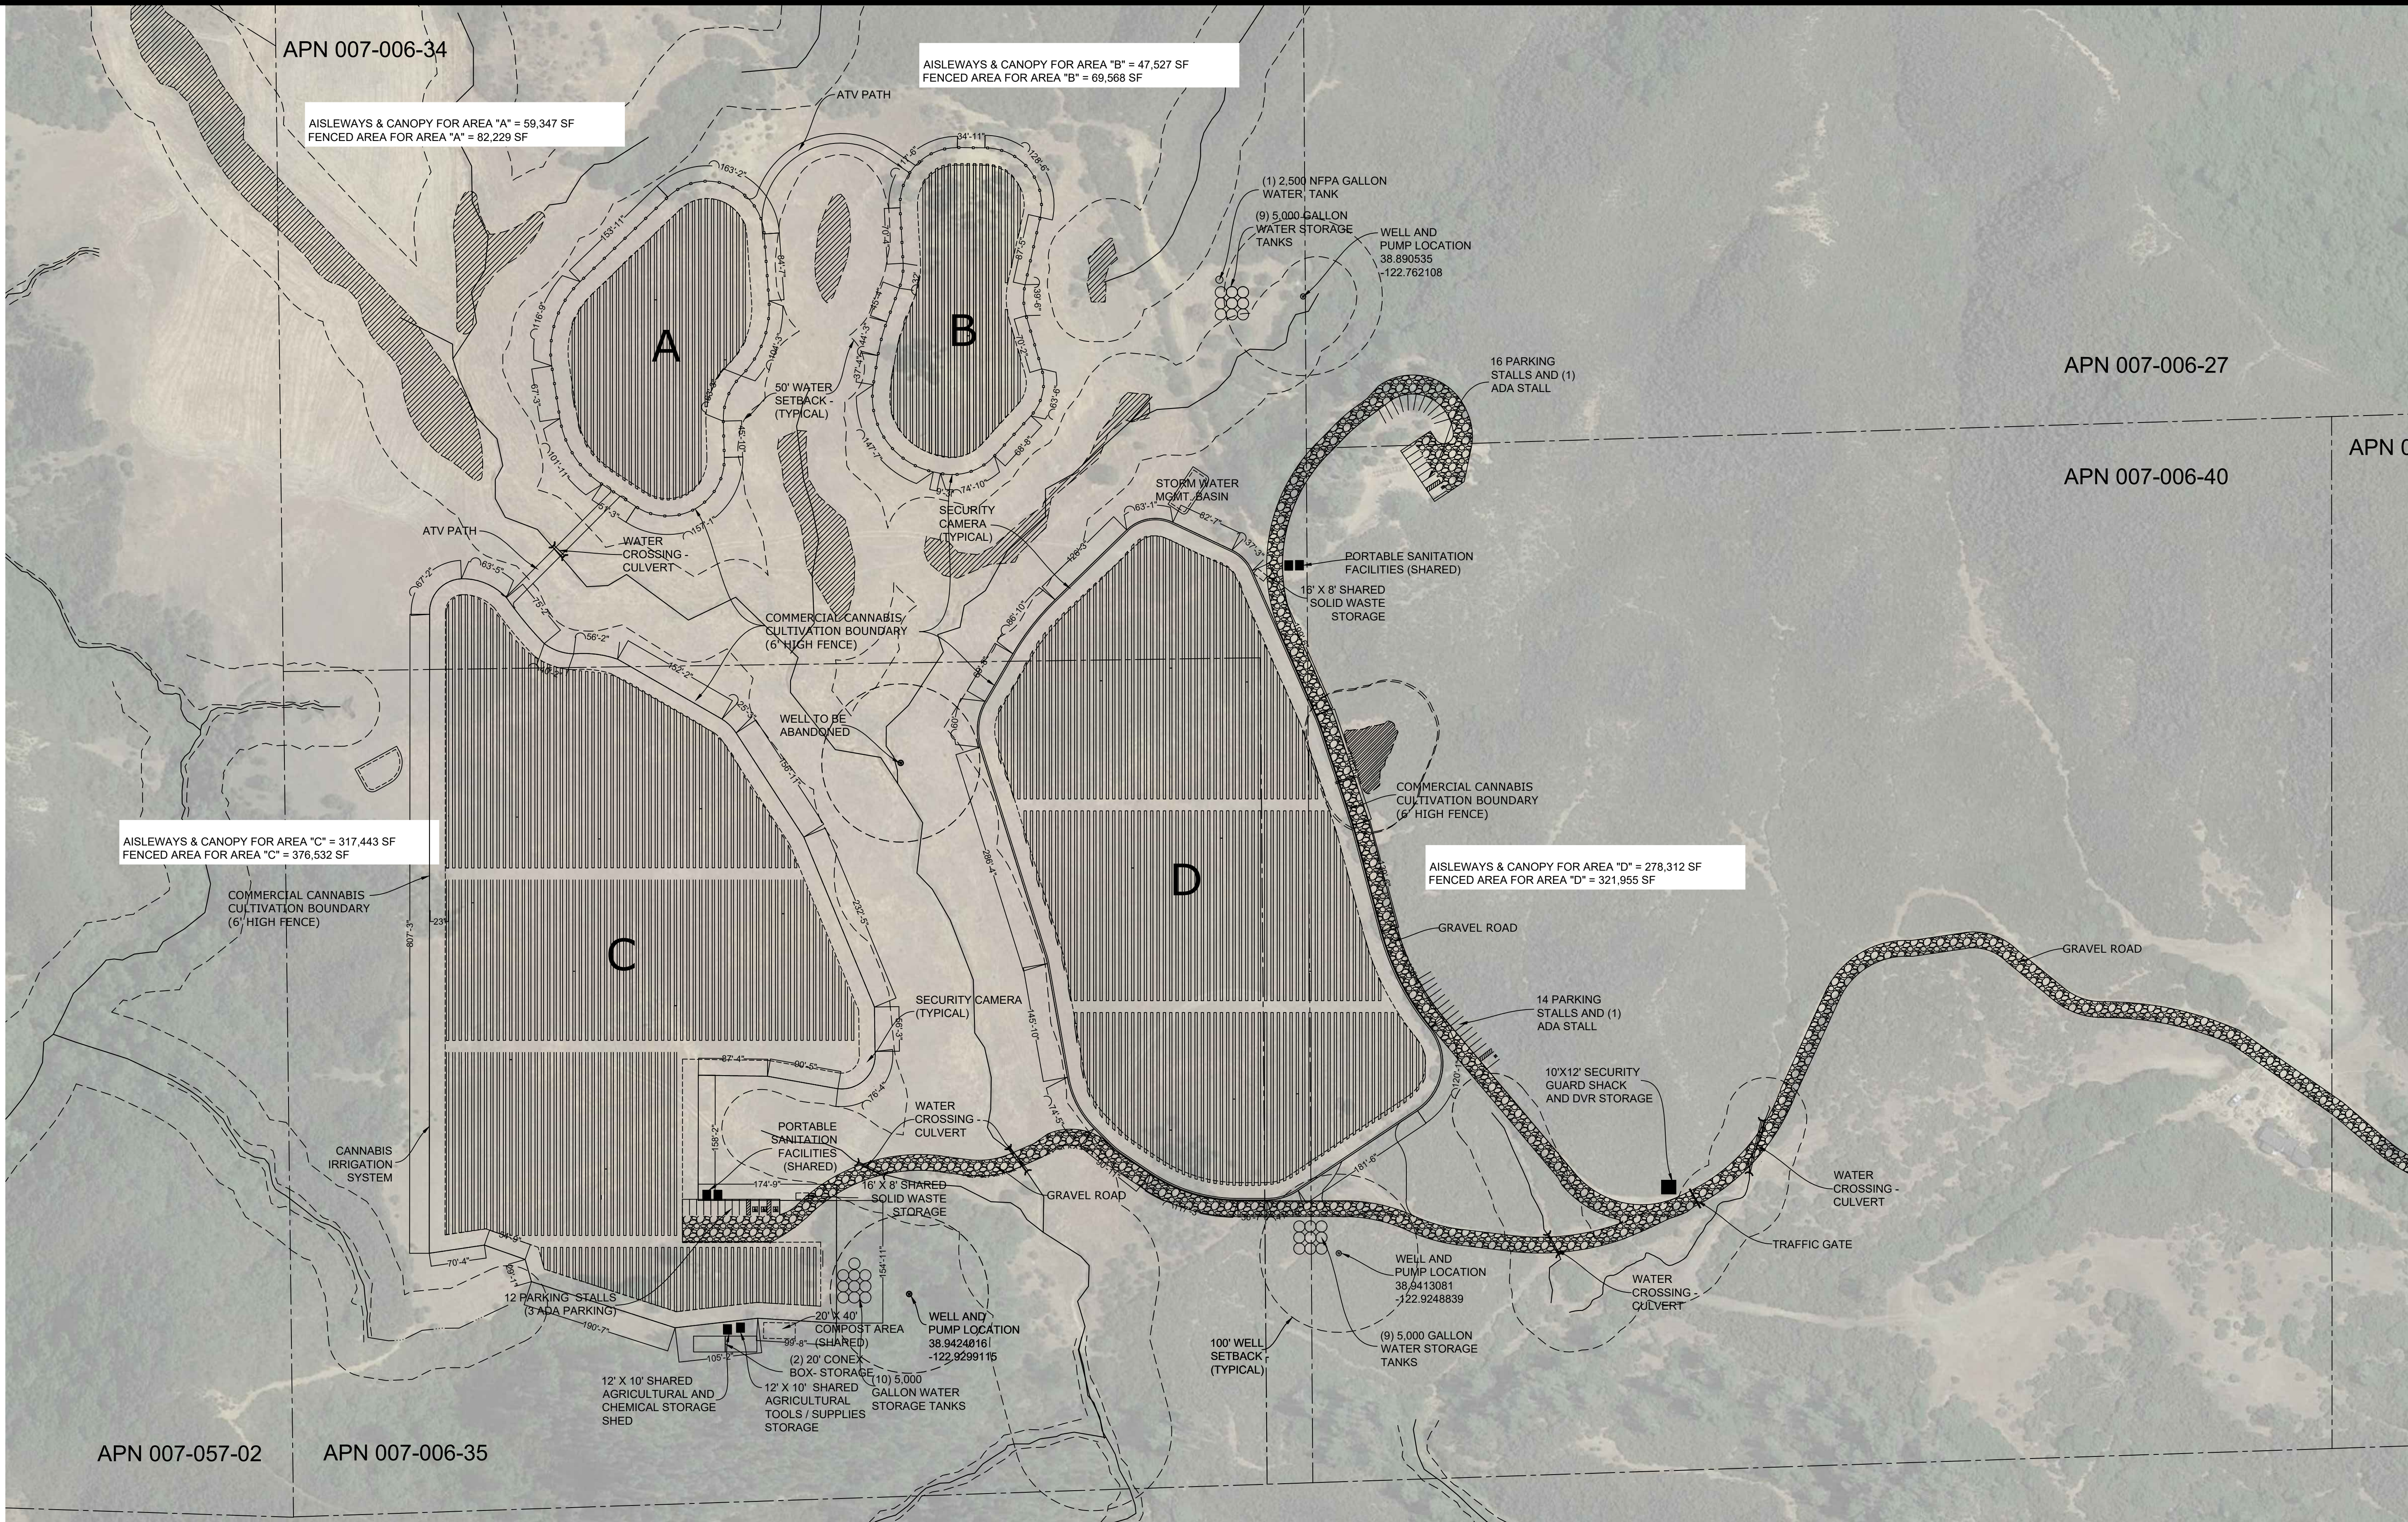

NOT FOR CONSTRUCTION

1 SITE PLAN- PHASE 1

1" = 100'

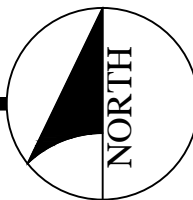


HIGHLAND FARMS, LP
CANNABIS CULTIVATION OPERATION
7408, 7533, 7527 & 7634, 7746 HIGHLAND SPRINGS RD
AND 7257 & 7357 AMBER RIDGE ROAD
LAKEPORT, CA 95453


SITE PLAN- PHASE 1

DATE ISSUED	10 NOV 23
INITIAL SUBMITTAL	27 OCT 20
DRAWN BY	WB
CHECKED BY	WB
JOB NO.	21038

EA-01

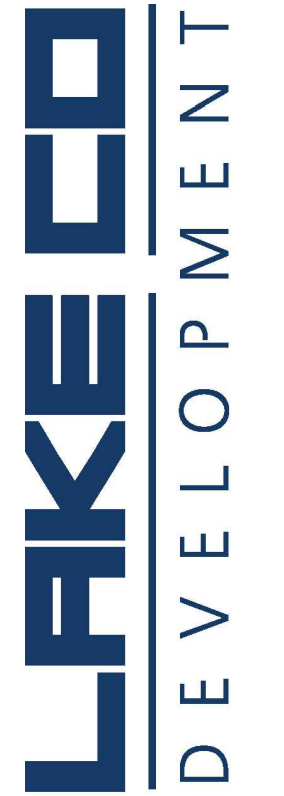



CONTACT:
AUTUMN KARCEY, CEO
(530) 379-8588
AUTUMN@LAKECODEVELOPMENT.COM

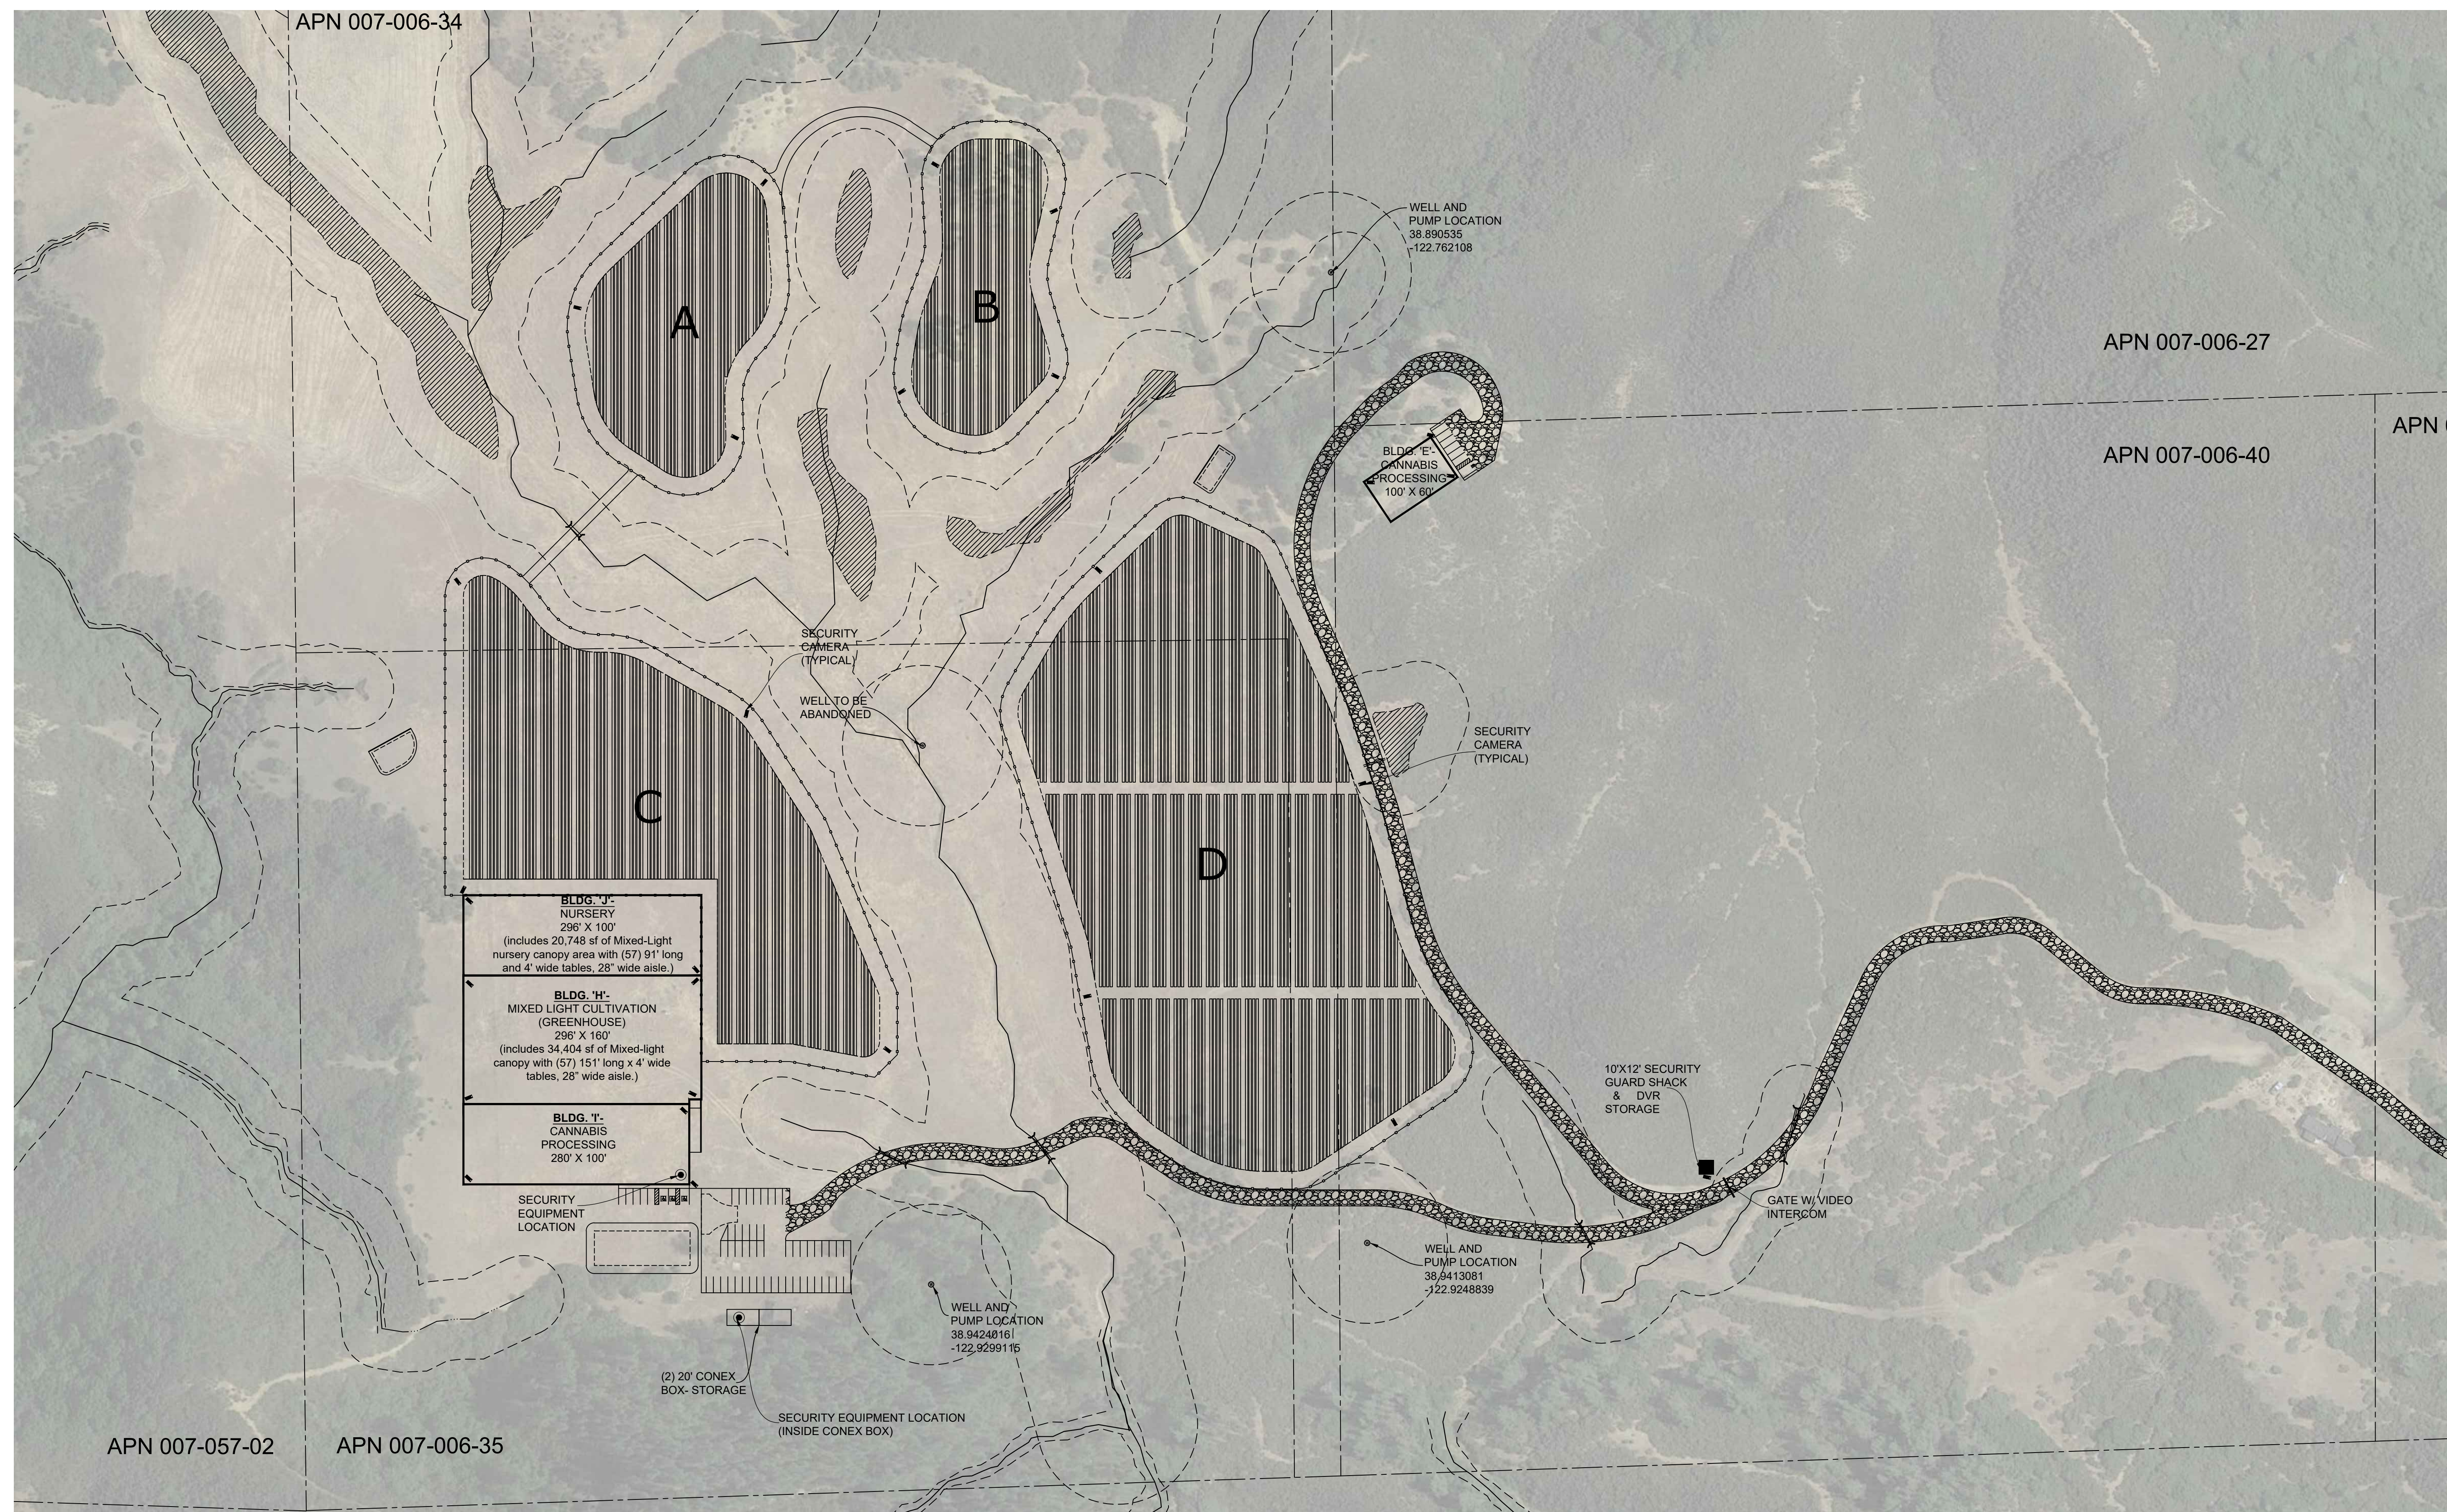

NOT FOR CONSTRUCTION

1 PHASE 2 - SECURITY PLAN

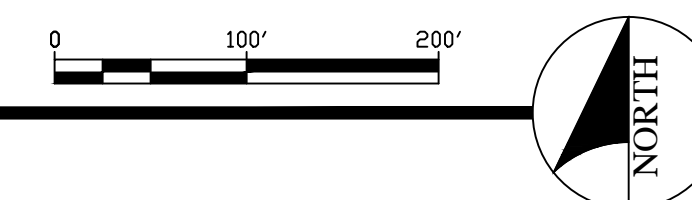

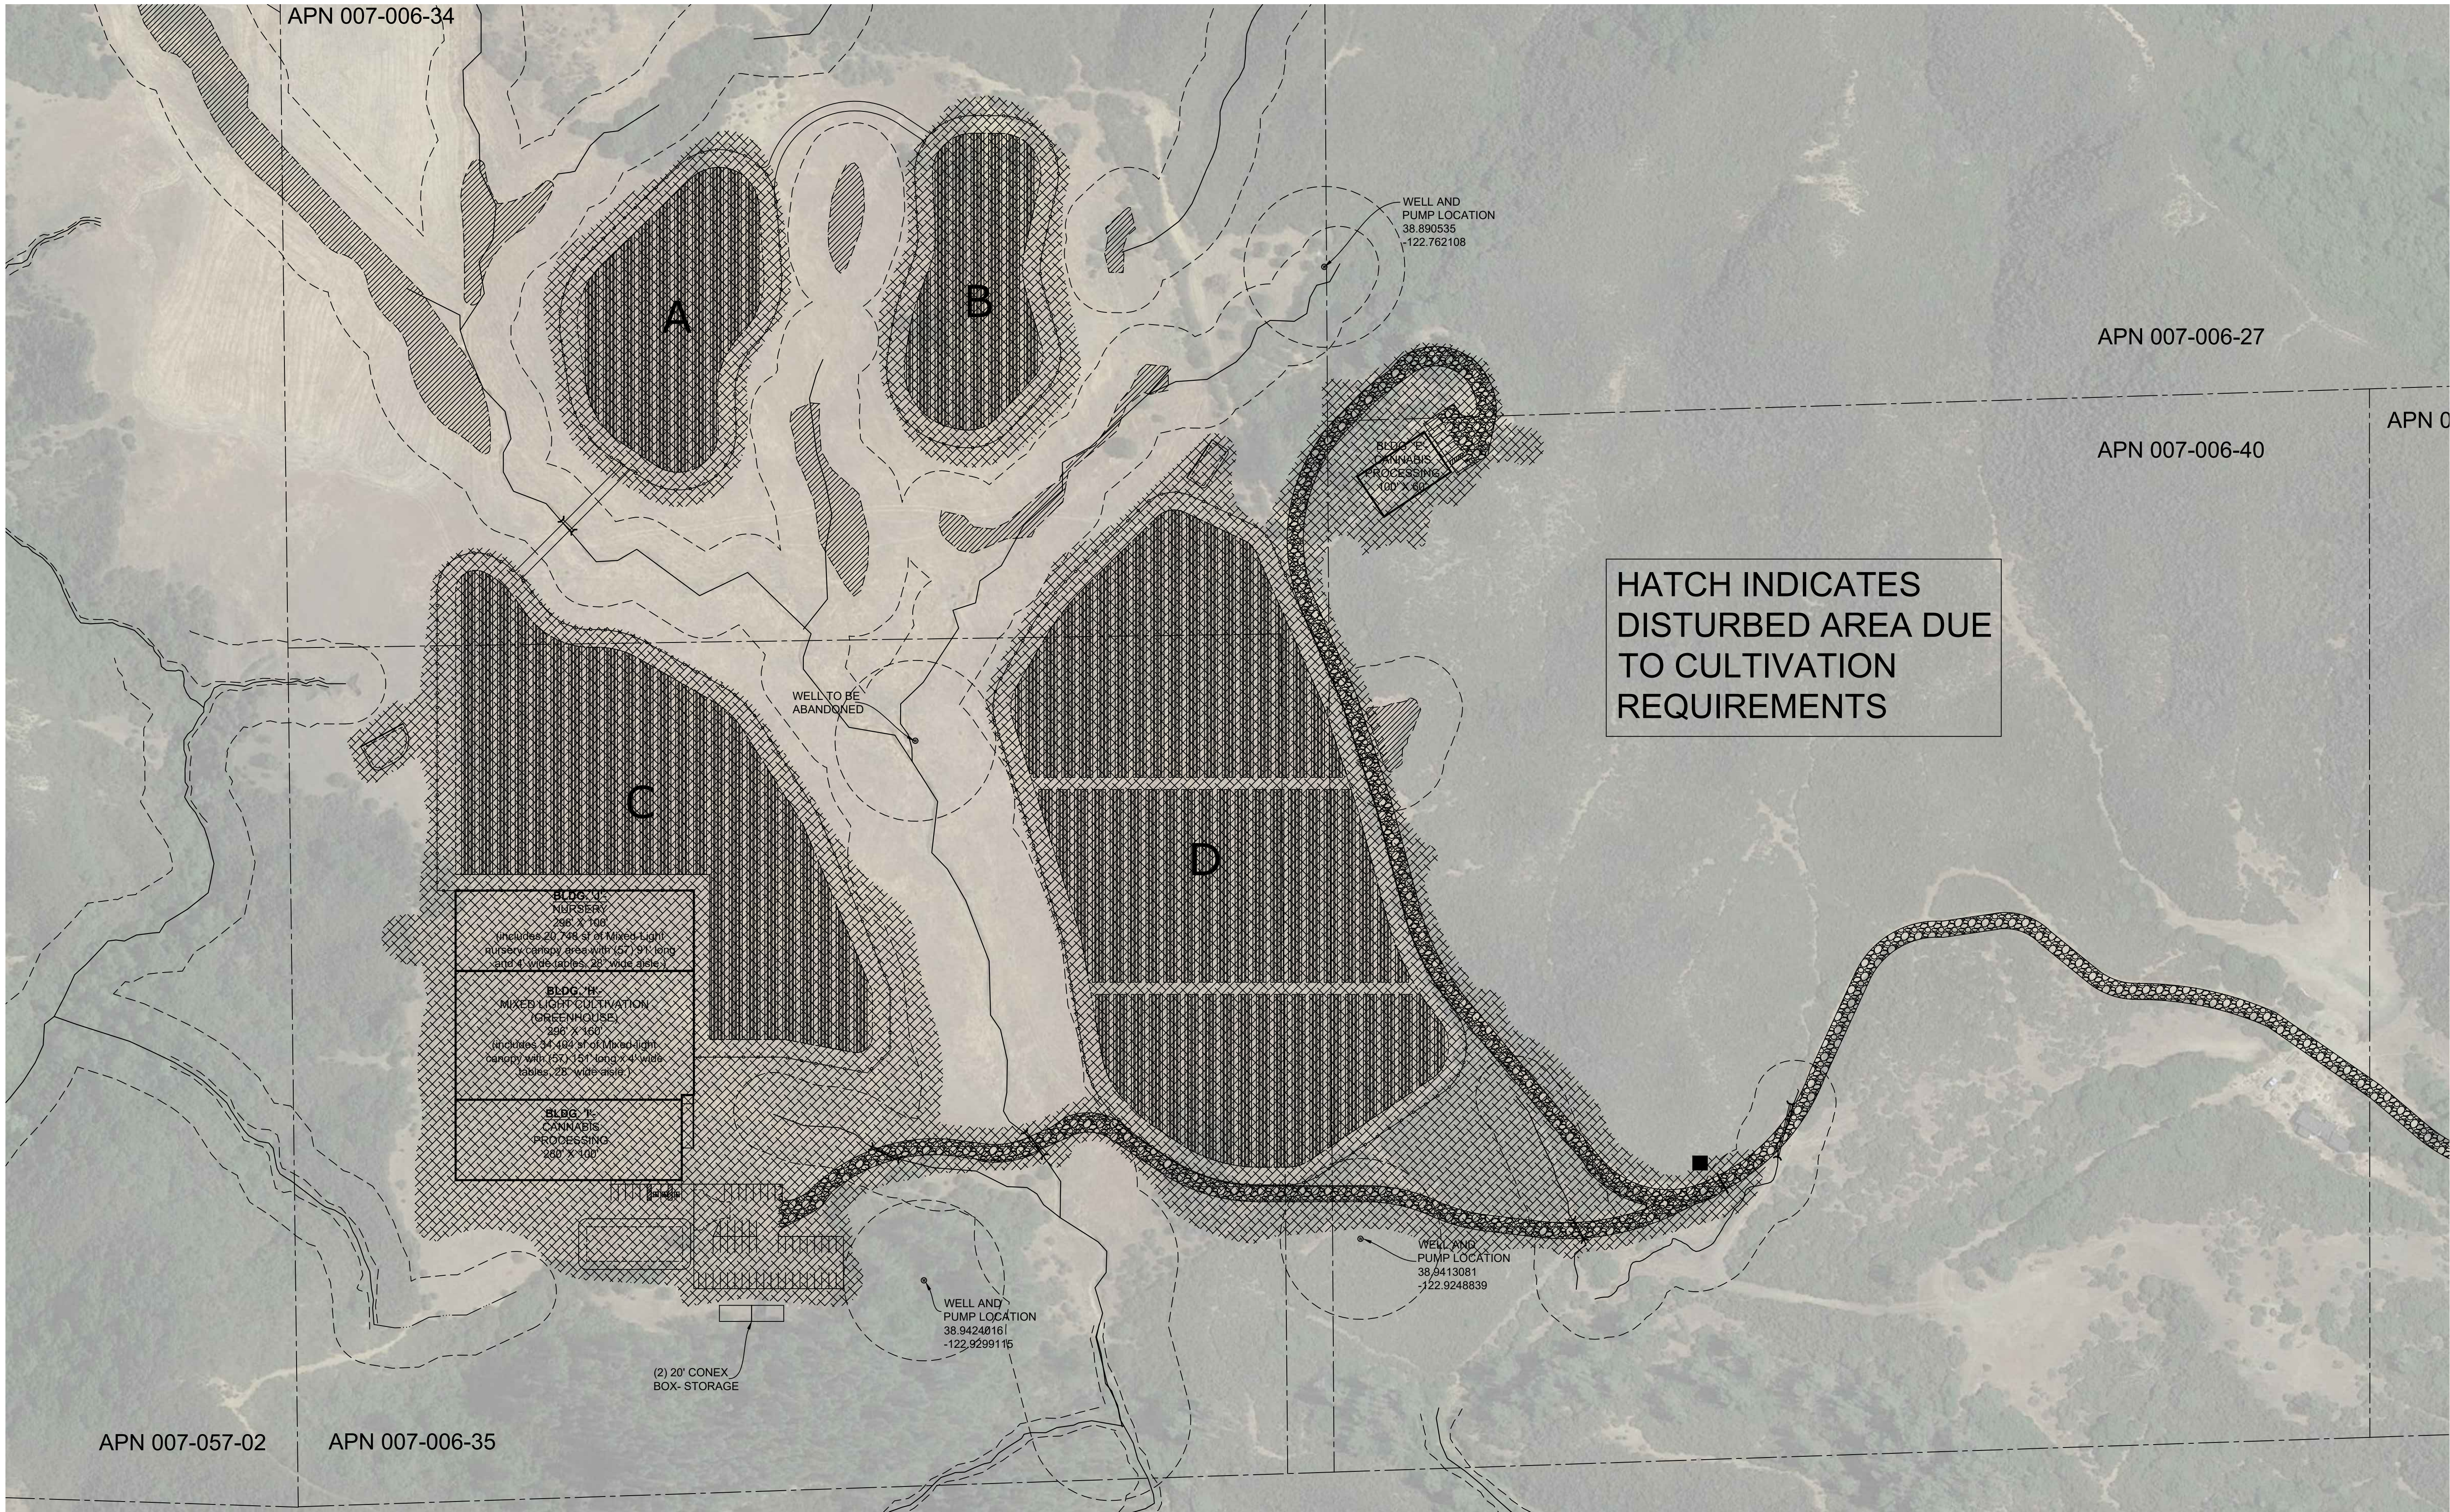

1 **DISTURBED AREA PLAN**
1" = 100'

NOT FOR CONSTRUCTION

HIGHLAND FARMS, LP
CANNABIS CULTIVATION OPERATION
7408, 7533, 7527 & 7634, 7746 HIGHLAND SPRINGS RD
AND 7257 & 7357 AMBER RIDGE ROAD
LAKEPORT, CA 95453

DISTURBED AREA PLAN

DATE ISSUED 10 NOV 23
INITIAL SUBMITTAL 27 OCT 20

DRAWN BY WB
CHECKED BY WB
JOB NO. 21038

MUP-04



CONTACT:
AUTUMN KARCEY, CEO
(530) 379-8588
AUTUMN@LAKECODEVELOPMENT.COM