


TITLE SHEET :
SITE PLAN

SHEET INDEX

- 1 COVER SHEET
PARCEL MAP
VICINITY MAP
- 2 SITE PLAN
- 3 EXISTING MAIN FLOOR PLAN
- 4 EXISTING LOWER FLOOR PLAN
DEMOLITION PLAN
- 5 NEW LOWER FLOOR PLAN
- 6 NEW LOWER FLOOR ELECTRICAL PLAN
- 7 NEW LOWER FLOOR PLUMBING PLAN

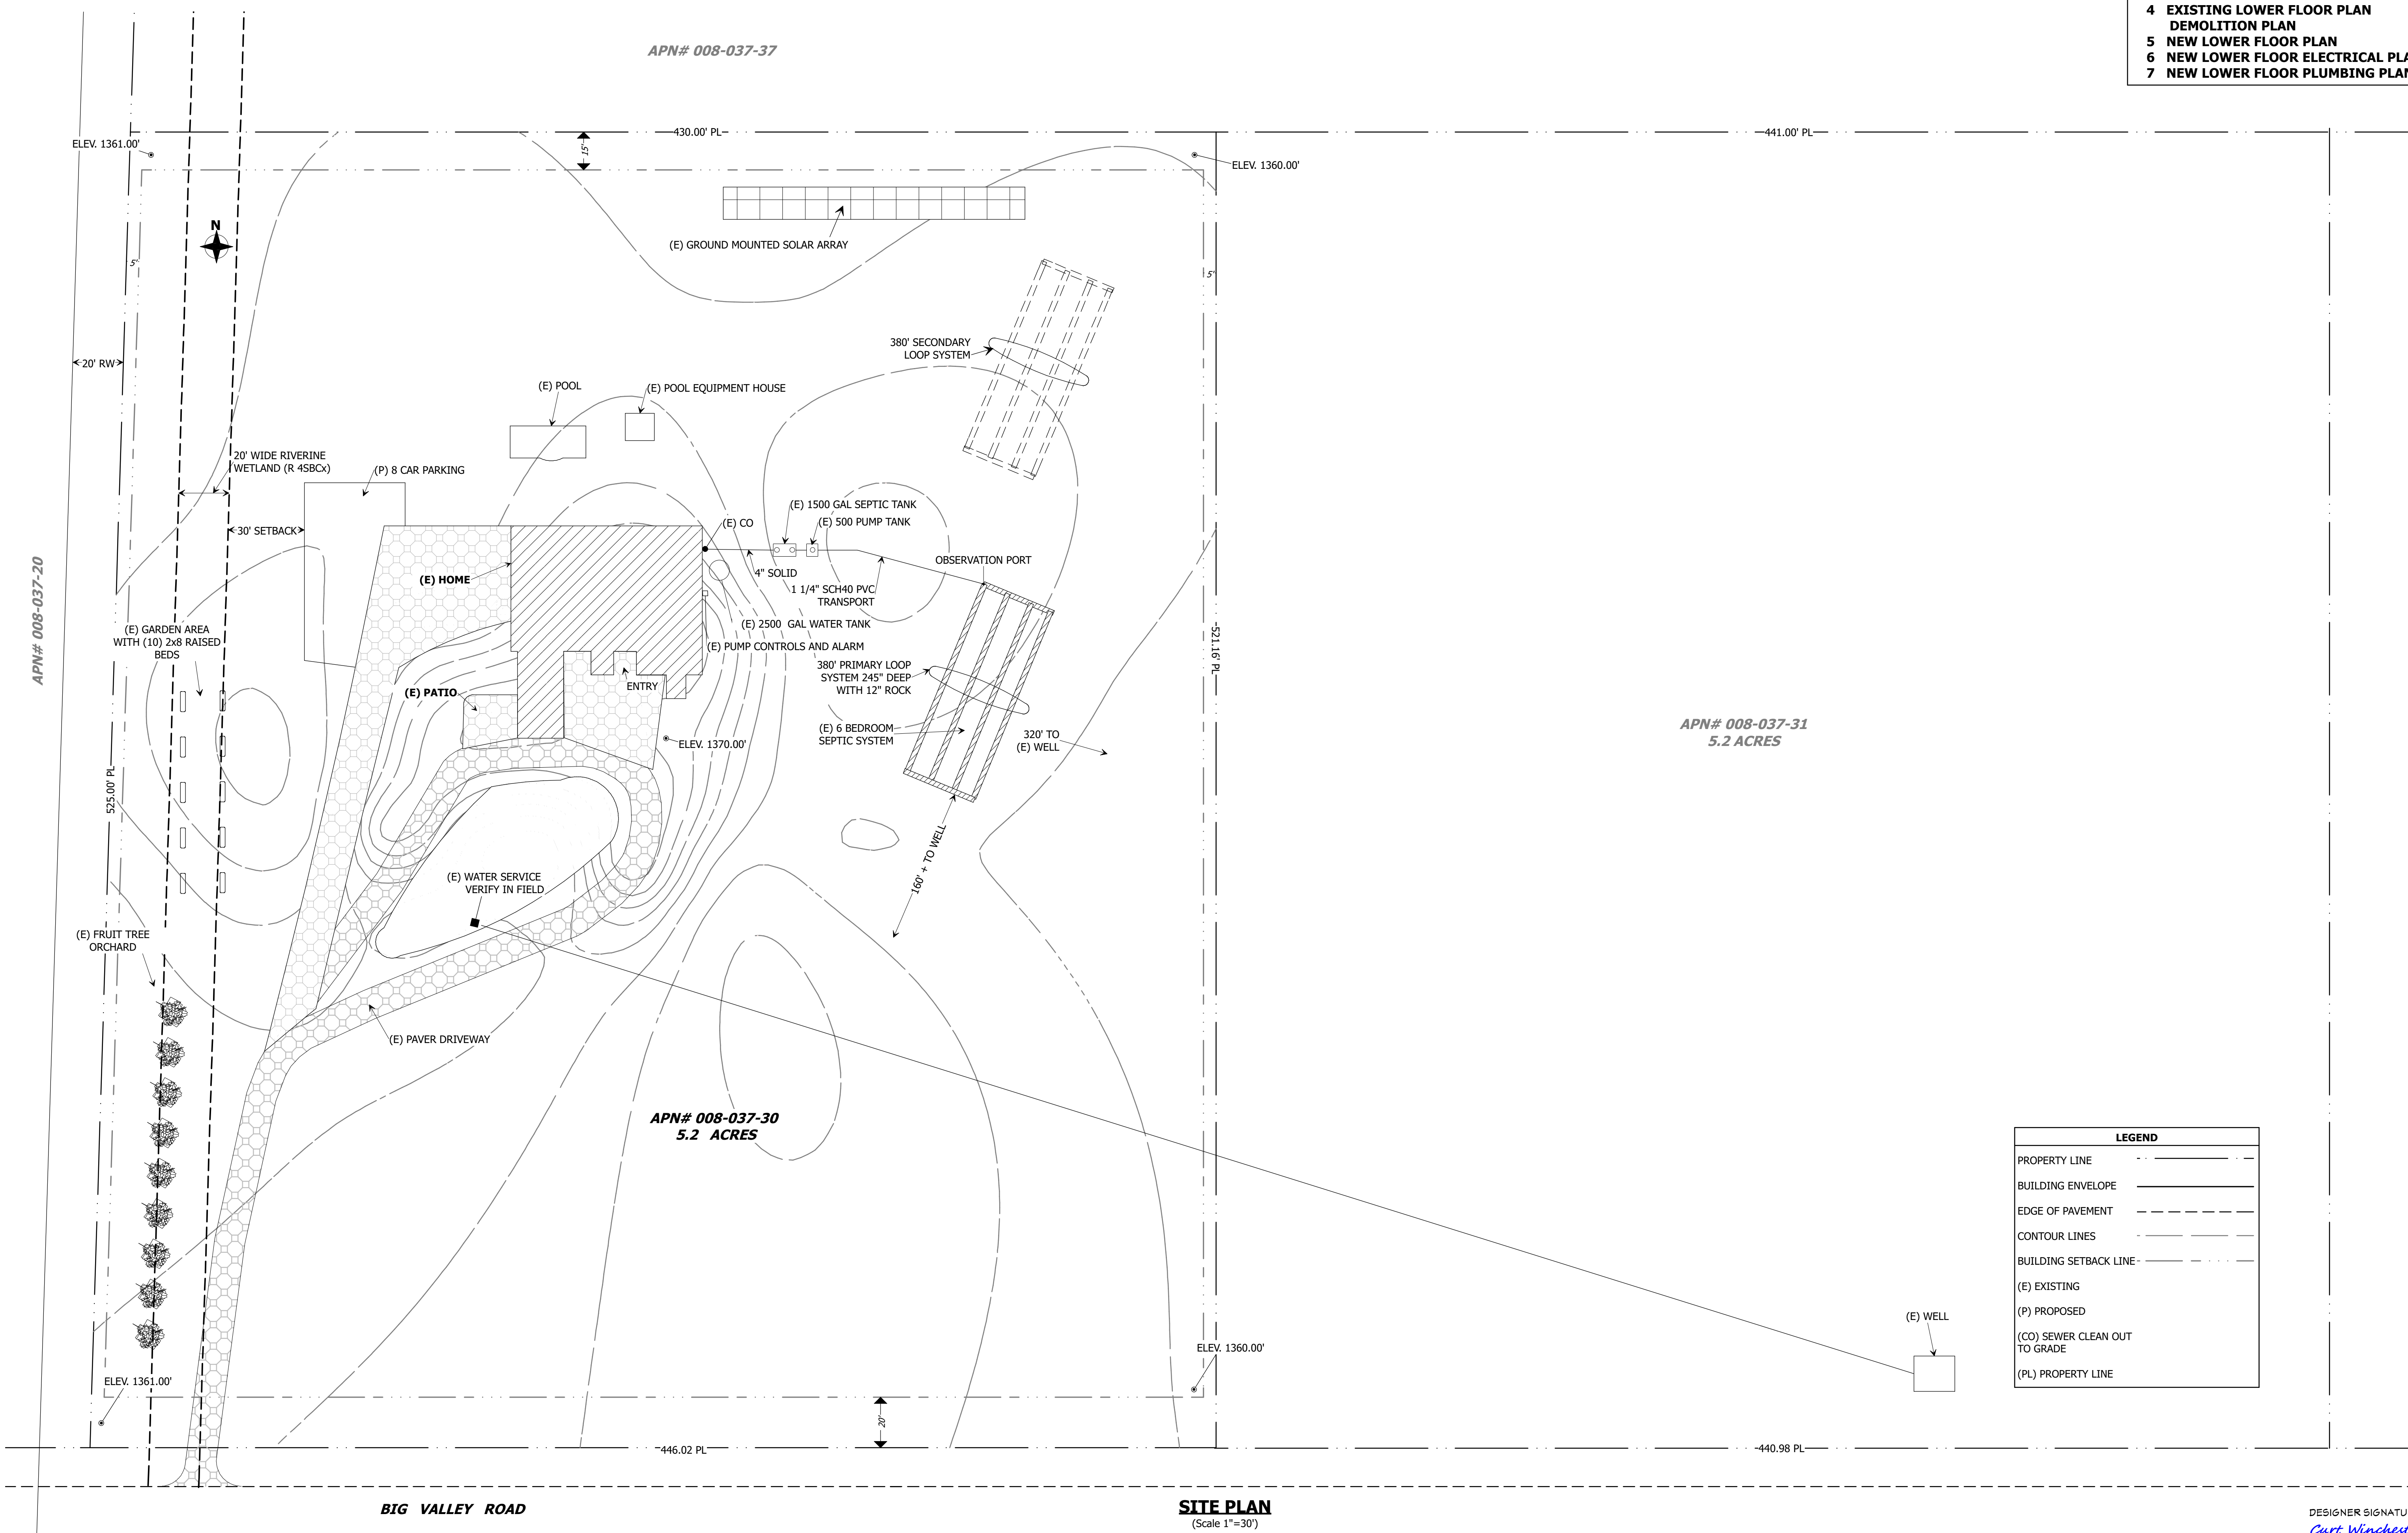

LEGEND	
PROPERTY LINE	---
BUILDING ENVELOPE	---
EDGE OF PAVEMENT	---
CONTOUR LINES	---
BUILDING SETBACK LINE	---
(E) EXISTING	
(P) PROPOSED	
(CO) SEWER CLEAN OUT TO GRADE	
(PL) PROPERTY LINE	

OWNER INFORMATION:
**MARA MEHLMAN &
JEVGENIJA SAROMOVA**
3210 BIG VALLEY ROAD
KELSEYVILLE, CA 95451

PROJECT INFORMATION:
008-037-30
3210 BIG VALLEY RD.
KELSEYVILLE, CA 95451

DESIGNED BY:
IN-SITE PROJECT PLANNING
8963 Hwy 175
Kelseyville, CA 95451
707-349-5959
in-site@live.com
Curt Winchester

DATE OF PRINTING:
7/19/2025

SCALE: 1/4"=1'
UON

DESIGN DATE:
7/19/25

SHEET :
2 of 6

DESIGNER SIGNATURE:
Curt Winchester